

**Legends:**


**Gross Internal Areas**  
**Compton Suite**  
**Total - 359m<sup>2</sup> (3864 ft<sup>2</sup>)**

**SYMBOLS LEGEND**

	ROLLER SHUTTERS UP/DOWN SWITCH
	SINGLE LIGHT SWITCH
	DOUBLE LIGHT SWITCH
	DIMMER LIGHT SWITCH
	DIMMER CONTROL PANEL
	BLANK PLATE
	SINGLE SOCKET
	DOUBLE SOCKET
	WALL MOUNTED DMX SOCKET
	WALL MOUNTED MICROPHONE SOCKET
	3 PHASE ISOLATOR PLUG SOCKET
	5amp (x10pin) SOCKET
	SINGLE DATA SOCKET
	DOUBLE DATA SOCKET
	ROOM TEMPERATURE CONTROL/DISPLAY
	FIRE EXIT SIGN
	FIRE BREAK GLASS POINT
	FIRE EXTINGUISHER (WATER)
	FIRE EXTINGUISHER (CARBON DIOXIDE)
	FIRE EXTINGUISHER (FOAM)
	FIRE EXTINGUISHER (POWDER)

Level Data	Fence Types
Spot Levels	BW Buried Wire
+ 99.75	CB Chain Barrier
	CC Compacted Iron
	CL Chain Link
	CP Chestnut Paving
	IR Iron Railing
	FF Flange Fence
	FR Flange Rail
	FW Flange Wire
	UK Unknown Tree Type

Abbreviations	Maximum Internal Height
ACU	Air Conditioner Unit
BA	Banner
BB	Bellows Beacon
BS	Ball Stop
BU	Bull
CA	Cable TV Cover
CH	Ceiling Height
CHC	Ceiling Height Change
CH	Clear Internal Height
CL	Clear Level
CPB	Concrete Paving Slabs
CUV	Ceiling Vents Up
DR	Door Height
DP	Down Pipe
DR	Drain
EH	Eaves Height
ER	Earth Road
FD	Floor Duct
FFL	Finished Floor Level
FL	Floor Level
PH	Fire Hydrant
QG	Quick Grass
H	Height
IC	Inspection Chamber
LP	Lamp Post
MH	Manhole
MH	Maximum Internal Height
OH	Overhead Height
PS	Post Box
PR	Painting Meter
PO	Post
RA	Rail
RE	Rodding Eye
RF	Raised Floor Void
RS	Road Sign
RRP	Road Rail Pipe
S	Sill
SD	Strip Duct
SC	Supporting Ceiling Height
SI	Sign Post
STN	Station
SV	Sub Vent
SV	Sub Vent Pipe
TAC	Trunk Access Cover
TC	Trapezoid Cover
TR	Telephone Box
TL	Traffic Light
TP	Telephone Pole
UC	Underground Cover
UNB	Underpass
UNB	Underpass CP Beam
UTL	Unstable To Lift
VP	Vent Pipe
WCH	Window Over Height

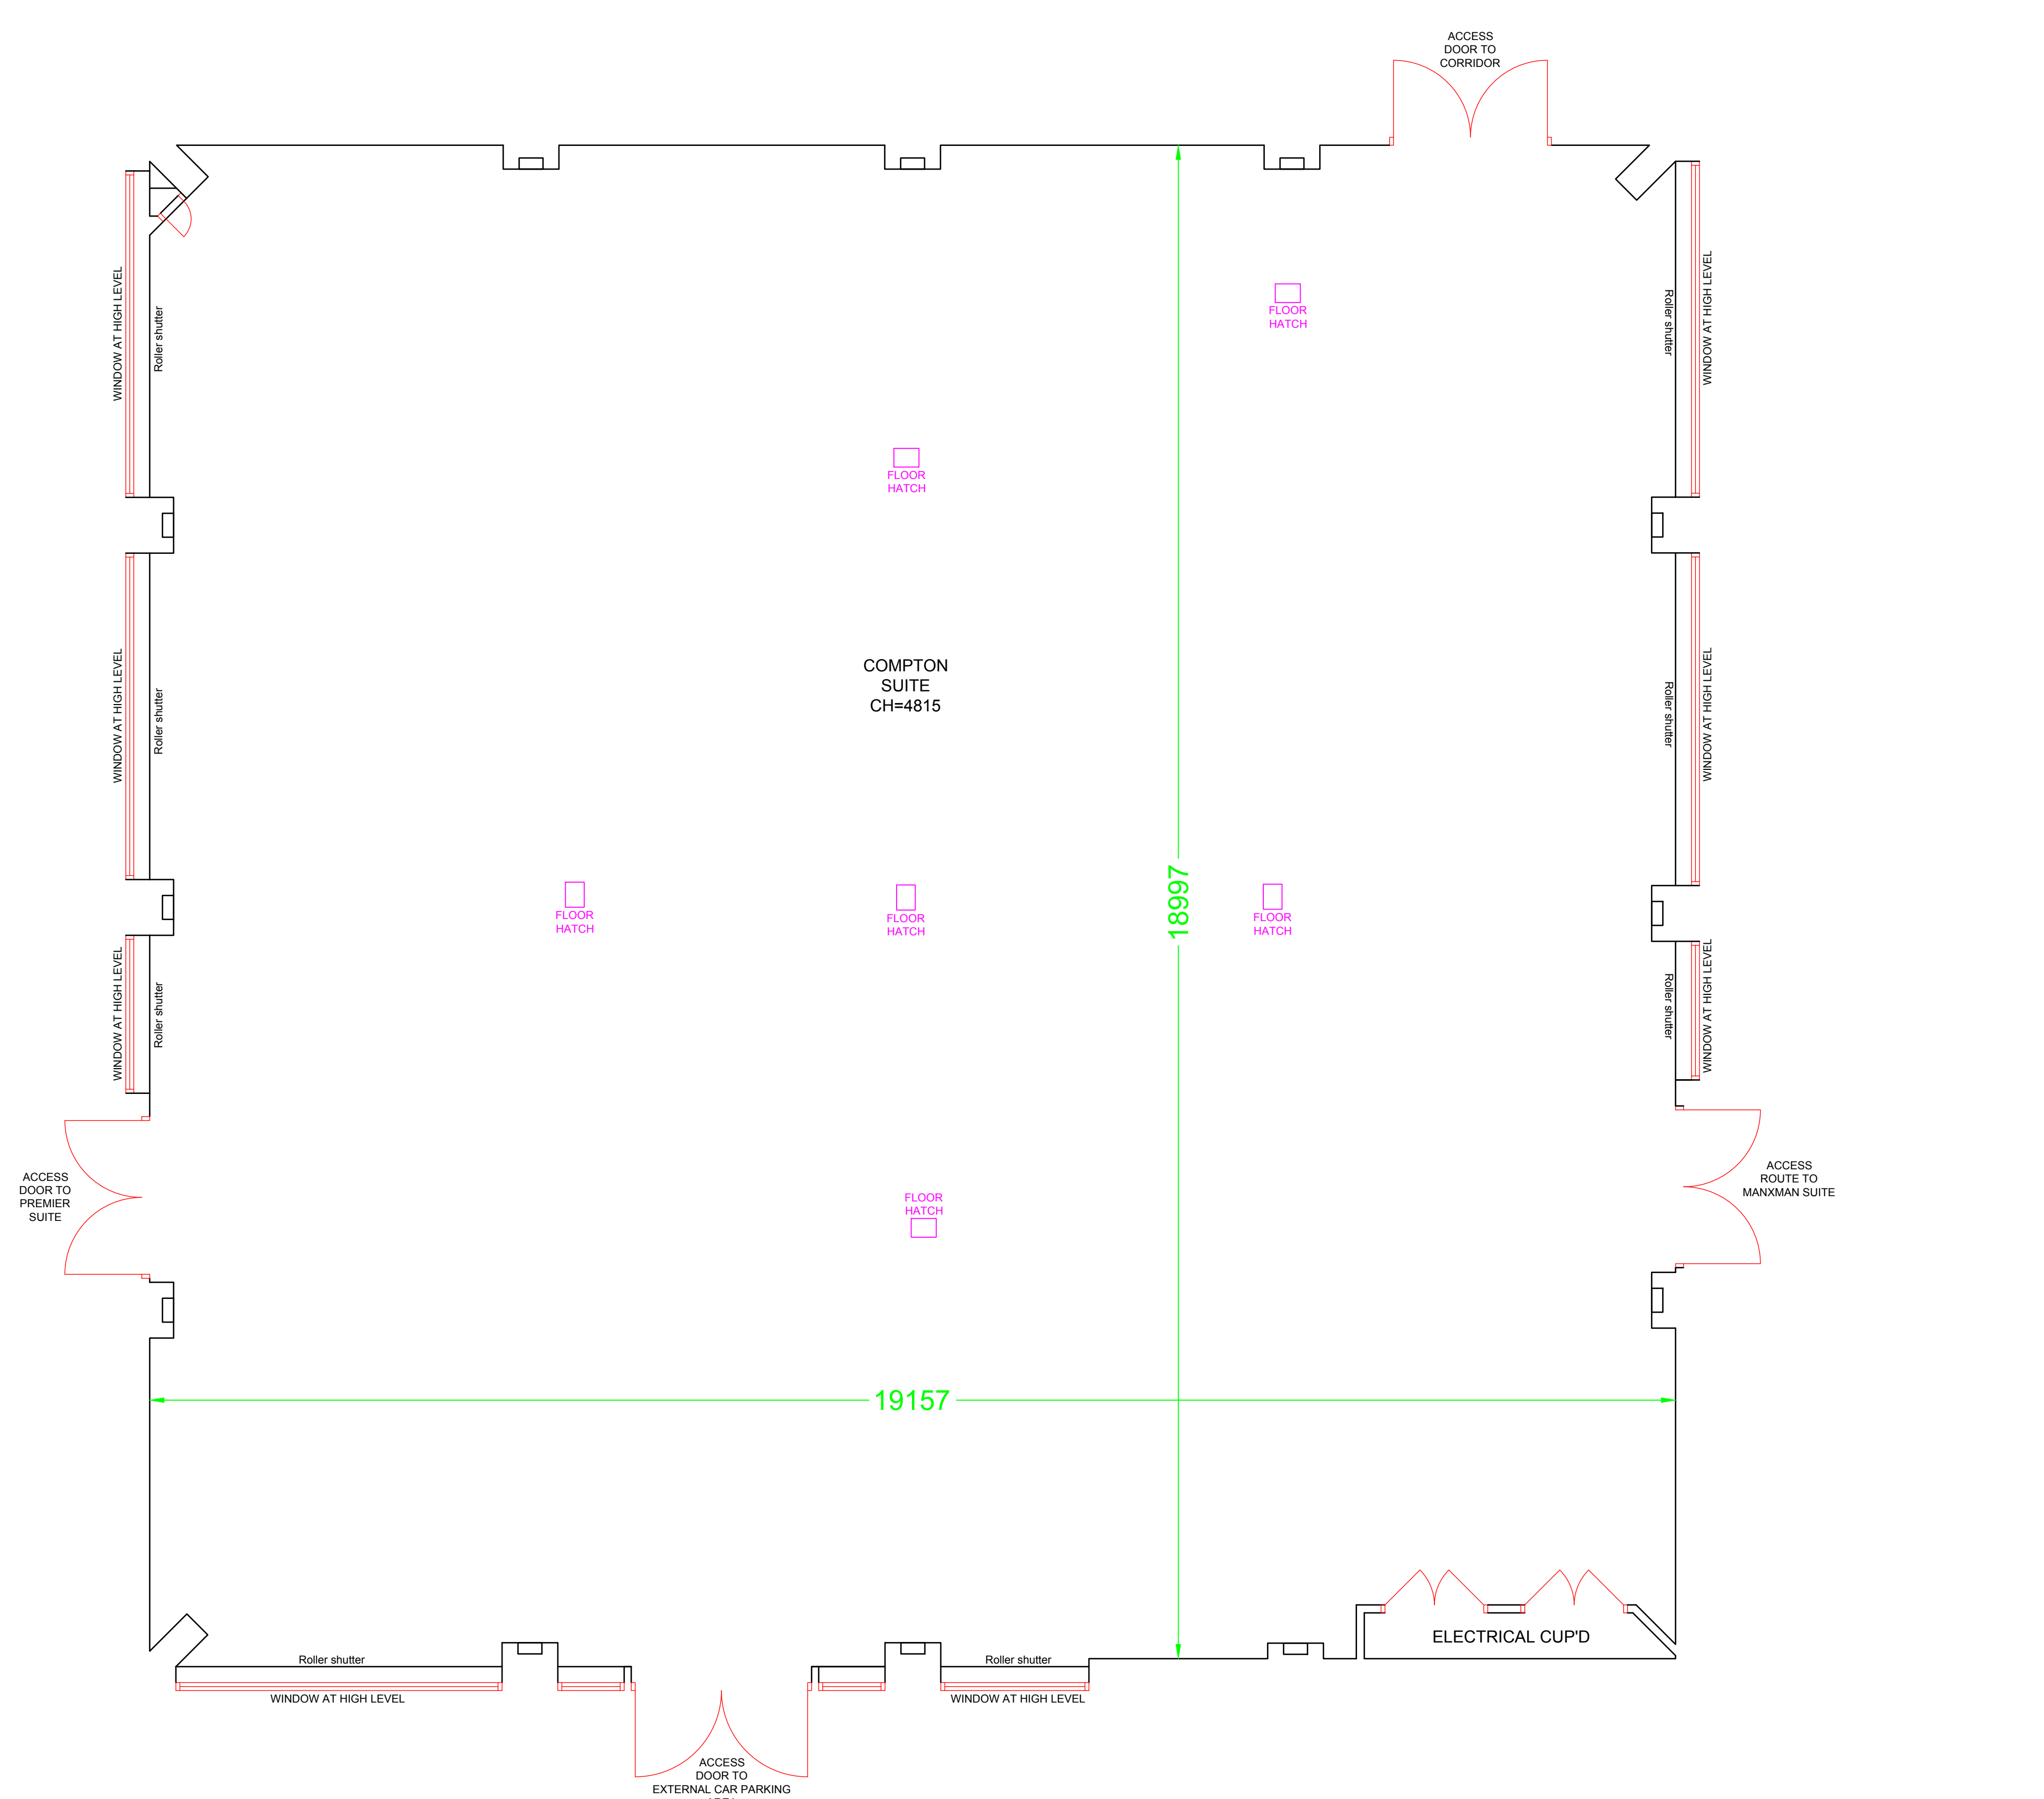

**(COMPTON SUITE) Ground floor**

REV.	DATE	BY	DESCRIPTION

**CADS**  
**Surveys**  
 C A Design Services Limited  
 The Design Centre, Hewett Road, Gapton Hall,  
 Great Yarmouth, Norfolk, NR31 0NN  
 Tel: 01493 440444 www.cadsdesignservices.co.uk  
 Registered in England No. 1595687

**CLIENT**  
**NATIONAL CONFERENCE CENTRE**

**SITE ADDRESS**  
**COVENTRY ROAD,  
 BICKENHILL,  
 SOLIHULL,  
 B92 0EJ**

**TITLE**  
**COMPTON SUITE  
 EXISTING FLOOR PLAN**

<b>DRAWN BY</b> LS	<b>DATE</b> JUNE 2016	<b>SCALE</b> 1/50@A1	<b>SHEET SIZE</b> A1
<b>CHECKED BY</b> LSIT	<b>DATE</b> JUNE 2016	<b>APPROVED BY</b> CADS	<b>DATE</b> JUNE 2016
<b>DRAWING No.</b> 31799_COMPTON	<b>REVISION</b> 0		